
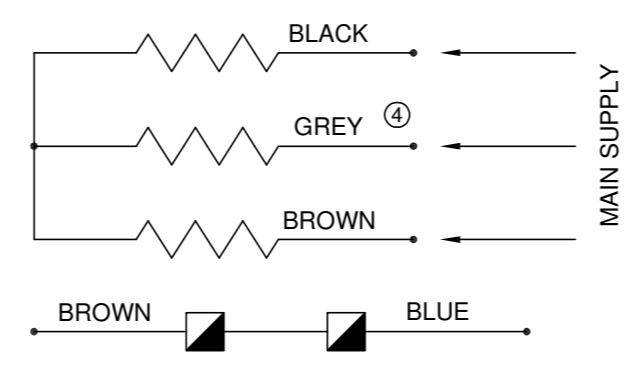


NOTE:
IMPELLER GRUB SCREW MUST BE TIGHTENED ONTO THE FLAT OF THE MOTOR SHAFT.

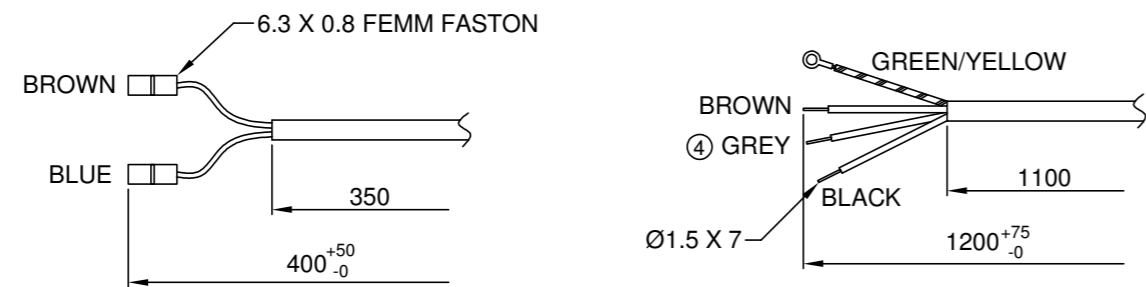

④ DDC321-321
400V 3 PHASE 50Hz
1100W 6 POLE 1 SPEED
CLASS F
PART No.083998
DATE CODE WW/YY
TORIN LIMITED, SWINDON, ENGLAND.
LABEL DETAIL

4	MAIN SUPPLY 2 LEAD CHANGED FROM BLUE TO GREY	09/10/08	17604
3	A.D.	26/06/06	16975
B	D.A.	16/09/02	16088
A	ISSUED	14/06/02	

ISS. MODIFICATION	DATE	C/N NO.
-------------------	------	---------

MATERIAL
GALV

FINISH
NATURAL

FIRST USED ON

SIMILAR TO
083998-01

DIRECTORY PATH
ASY/DDC/321-321/WF/083998

TITLE
**DDC321-321 400V 50Hz
3 PHASE 1100W 6 POLE
1 SPEED CLASS F**

DRAWING NO.
083998

Torin Limited
Drakes Way
Swindon Wiltshire
SN3 3JB
Tel : (01793) 524291

THIS DRAWING AND SPECIFICATIONS IS THE EXCLUSIVE PROPERTY OF TORIN LIMITED, ISSUED IN STRICT CONFIDENCE AND SHALL NOT BE REPRODUCED, COPIED OR USED FOR ANY REASON OTHER THAN WHICH IT IS ISSUED, WITHOUT THE WRITTEN PERMISSION OF TORIN LIMITED.
© TORIN LIMITED

PROJECTION

DRAWING GENERALLY CONFORMS TO BS 8888

ALL BS TO LATEST ISSUE

DR. DA	CHKD	AP.	A2
DATE 14/06/02	DATE	DATE	
DIMENSIONS IN MILLIMETRES			866380
SCALE: NTS (UNLESS OTHERWISE STATED)			

DRAWING NO.
866380